


GENERAL NOTES:


1. ALL INTERCONNECTING PIPING, ACCESSORIES, AND PIPE FITTINGS SHALL BE SUPPLIED AND INSTALLED BY THE CONTRACTOR.
2. ALL PIPING SHALL BE HARD-DRAWN SEAMLESS TYPE "K" OR "L" COPPER TUBING CONFORMING TO ASTM DESIGNATION B-819.
3. ALL PIPING SHALL BE INSTALLED IN ACCORDANCE WITH NFPA 99. PIPING LAYOUT IS DIAGRAMMATIC ONLY. FINAL ARRANGEMENT WILL BE SITE SPECIFIC. CONTRACTOR WILL BE RESPONSIBLE FOR FIELD VERIFICATION AND COORDINATING ACTUAL LOCATIONS WITH ALL OTHER TRADES.
4. CONTRACTOR SHALL VERIFY MOTOR VOLTAGE, PHASE AND AMP RATINGS BEFORE STARTING ELECTRICAL INSTALLATION AND MAKE CERTAIN THE VOLTAGE SUPPLIED BY THE HOSPITAL IS THE SAME.
5. THE ROOM REQUIRES DEDICATED MECHANICAL VENTILATION WITH AN ALLOWABLE TEMPERATURE VARIANCE OF 40° TO 105°F. (FOR HIGHER AMBIENTS, CONSULT FACTORY).
6. ELECTRICAL POWER SHOULD BE SUPPLIED FROM THE EQUIPMENT SYSTEM BRANCH OF THE ESSENTIAL ELECTRICAL SYSTEM (EMERGENCY POWER).
7. EQUIPMENT, INSTALLATION, AND TESTING OF THE MEDICAL AIR SYSTEM SHALL COMPLY WITH NFPA 99, AND ALL STATE AND LOCAL CODES OR ORDINANCES.
8. WHEN DETERMINING THE TOTAL PIPE LENGTH, ADD ALL THE STRAIGHT LENGTHS OF PIPE TOGETHER IN ADDITION TO THE NUMBER OF ELBOWS TIMES THE EFFECTIVE PIPE LENGTH FOR THAT PIPE SIZE. (SEE EQUIVALENT PIPE LENGTH TABLE & EXAMPLE CALCULATION IN O & M MANUAL)
9. ALLOW 36 INCHES IN FRONT OF CONTROL PANEL FOR MAINTENANCE AND VENTILATION, ALL OTHER SIDES REQUIRE 24 INCHES OF CLEARNACE.

INTAKE PIPE SIZE TABLE (SEE NOTE 8)				
UNIT SIZE	PIPE LENGTH			
	0-100'	101'-250'	251'-450'	451'-500'
QPX 10	3.00" NPT	3.50" NPT	4.00" NPT	5.00" NPT
UNIT SIZE	PIPE LENGTH			
	0-50'	51'-100'	101'-200'	201'-500'
QPX 15	3.00" NPT	3.50" NPT	4.00" NPT	5.00" NPT

EFFECTIVE PIPE LENGTH FOR ELBOWS				
PIPE SIZE (IN)	3.00" NPT	3.50" NPT	4.00" NPT	5.00" NPT
EFF. PIPE LENGTH (FT)	7.9	9.4	10	11.9

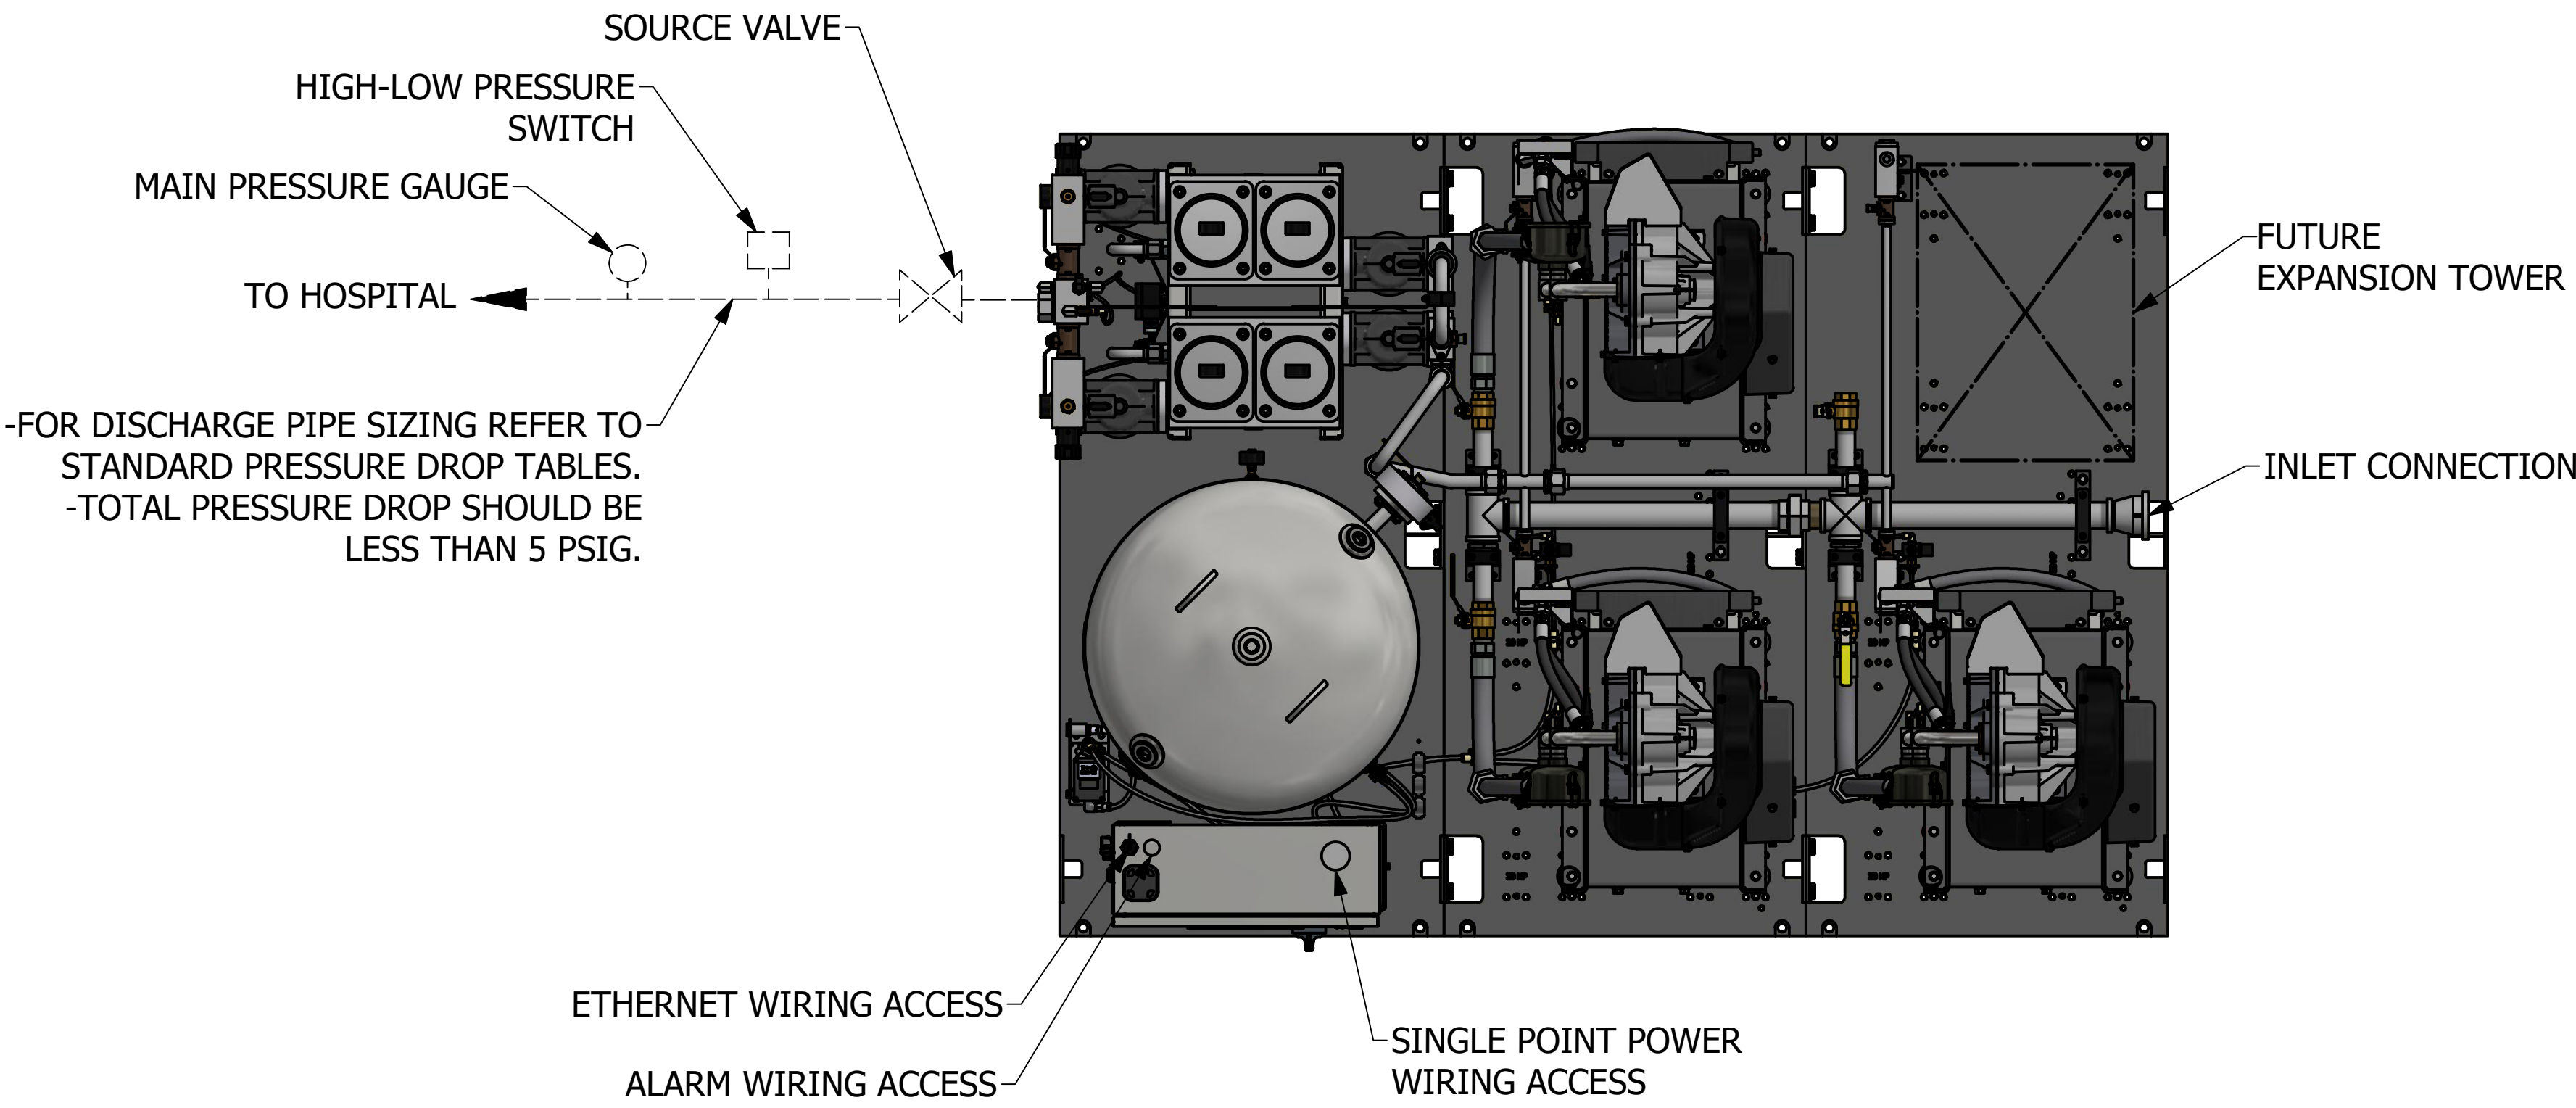

DISCHARGE CONNECTION

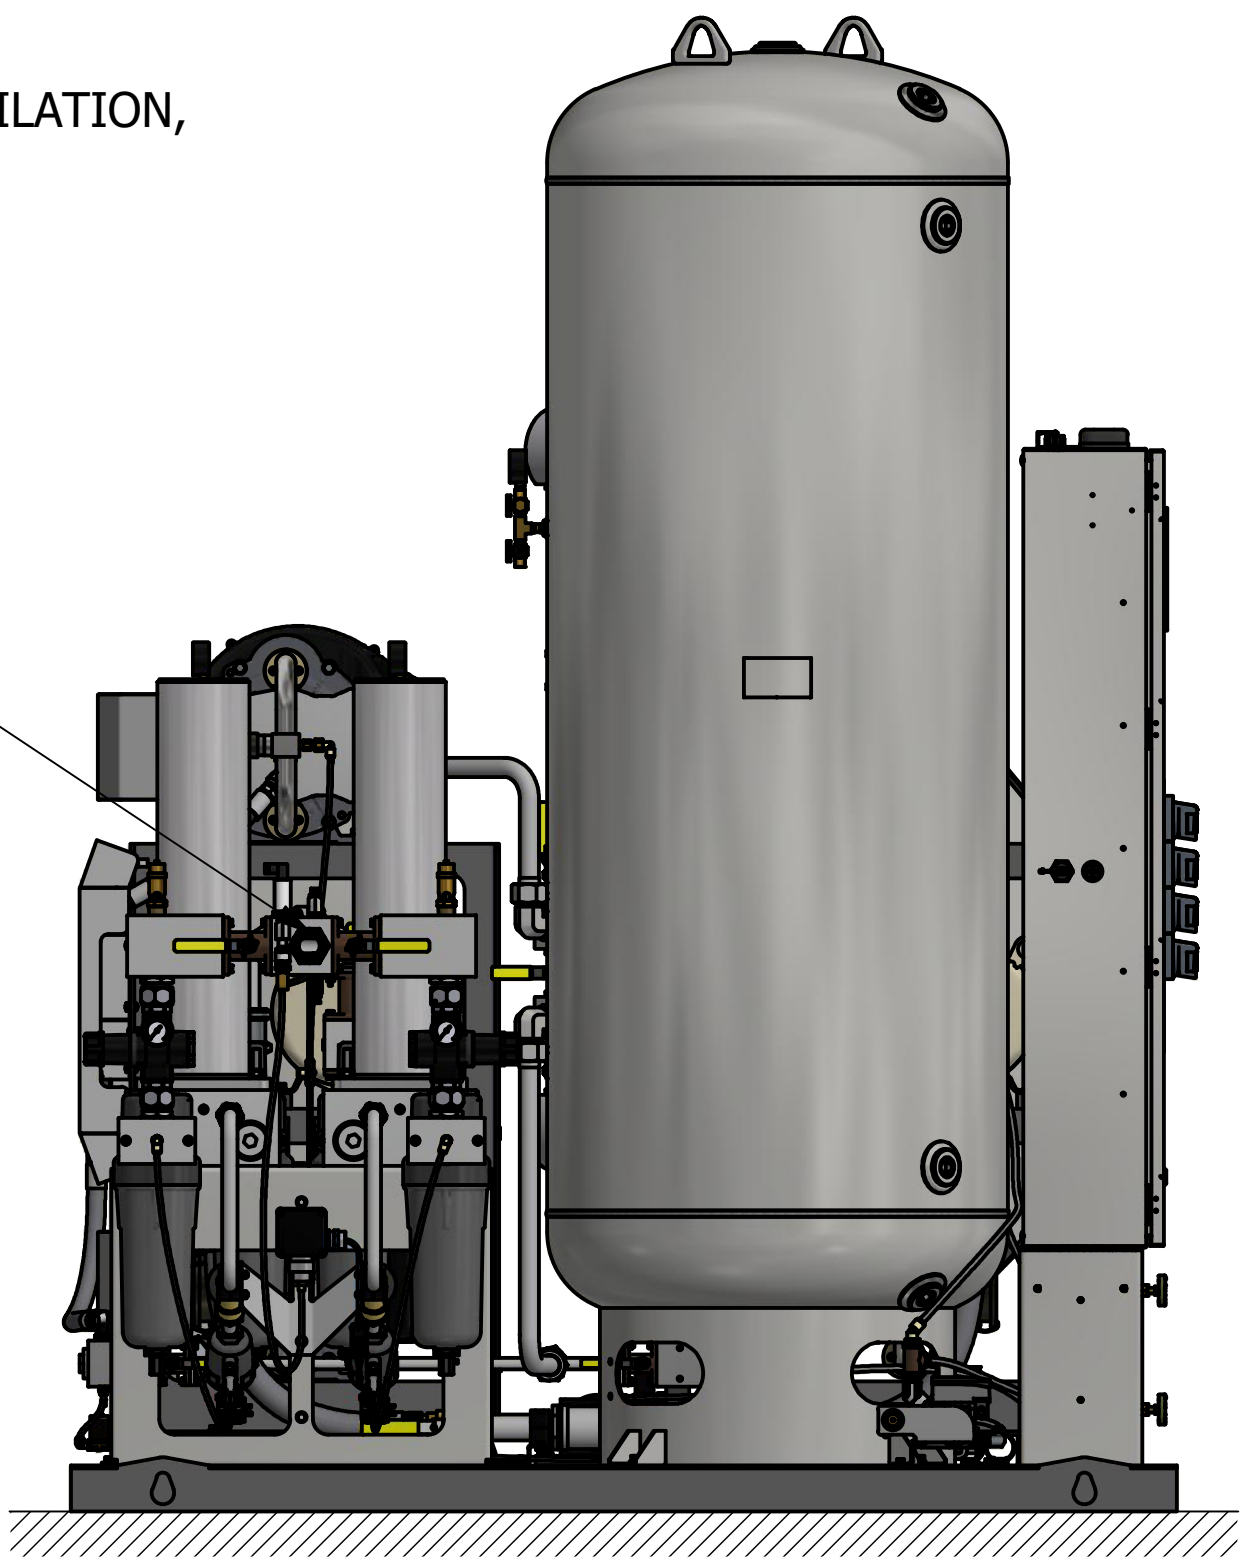

SINGLE POINT DRAIN CONNECTON, CONTRACTOR SHALL PIPE TO FLOOR DRAIN

NO VIBRATION PADS ARE NECESSARY AT THIS LOCATION

NO FOUNDATION OR INERTIA PAD IS REQUIRED (HOUSEKEEPING PAD IS OPTIONAL)

PIPE INTAKE TO OUTSIDE, TURN DOWN AND SCREEN PER NFPA 99. (REF. TO TABLE FOR CORRECT PIPE SIZING)

HEAVY-DUTY 4-POINT ISOLATION (SEISMIC OPTIONAL)

NOTE:  
ALL ACCESSORIES, PIPE, AND FITTINGS BEYOND INLET AND DISCHARGE PORTS ARE SUPPLIED AND INSTALLED BY OTHERS.

(15HP WITH 240 GALLON RECEIVER SHOWN)

Revised: APS	Date: 3/1/2023	Drawn: Jeb	Date: 11/19/2009
BEACONMEDAES		This drawing and the information contained therein remain the property of BeaconMedaes and may not be used for other than the purpose for which it is loaned without the expressed written permission from BeaconMedaes Engineering.	
Description: INSTALLATION DIAGRAM 10-15HP TX-EXP-QX SCROLL SPC		Part Number: 4107 8511 95	
DN: HOP230837		Rev: 03	
Sheet 1 of 1		DO NOT SCALE THIS DOCUMENT	