

GENERAL NOTES:

1. ALL INTERCONNECTING PIPE AND FITTINGS SHALL BE INSTALLED BY THE CONTRACTOR.
2. ALL PIPING SHALL BE HARD-DRAWN SEAMLESS TYPE "K" OR "L" COPPER TUBING CONFORMING TO ASTM DESIGNATION B-819.
3. ALL PIPING SHALL BE INSTALLED IN ACCORDANCE WITH NFPA 99. PIPING LAYOUT IS DIAGRAMMATIC ONLY. FINAL ARRANGEMENT WILL BE SITE SPECIFIC. CONTRACTOR WILL BE RESPONSIBLE FOR FIELD VERIFICATION AND COORDINATING ACTUAL LOCATION WITH ALL OTHER TRADES.
4. CONTRACTOR SHALL VERIFY MOTOR VOLTAGE, PHASE, AND AMP RATINGS BEFORE STARTING ELECTRICAL INSTALLATION; AND MAKE CERTAIN THE VOLTAGE SUPPLIED BY THE HOSPITAL IS THE SAME.
5. THE ROOM REQUIRES DEDICATED MECHANICAL VENTILATION WITH AN ALLOWABLE TEMPERATURE VARIANCE OF 40° TO 105°. (FOR HIGHER AMBIENTS, CONSULT FACTORY).
6. ELECTRICAL POWER SHOULD BE SUPPLIED FROM THE EQUIPMENT SYSTEM BRANCH OF THE ESSENTIAL ELECTRICAL SYSTEM (EMERGENCY POWER).
7. EQUIPMENT, INSTALLATION, AND TESTING OF THE MEDICAL AIR SYSTEM SHALL COMPLY WITH NFPA 99, AND ALL STATE AND LOCAL CODES OR ORDINANCES.
8. WHEN DETERMINING THE TOTAL PIPE LENGTH, ADD ALL THE STRAIGHT LENGTHS OF PIPE TOGETHER IN ADDITION TO THE NUMBER OF ELBOWS TIMES THE EFFECTIVE PIPE LENGTH FOR THAT PIPE SIZE. (SEE EQUIVALENT PIPE LENGTH TABLE & EXAMPLE CALCULATION IN THE O&M MANUAL)
9. ALLOW 36 INCHES IN FRONT OF CONTROL PANEL FOR MAINTENANCE AND VENTILATION, ALL OTHER SIDES REQUIRE 24 INCHES OF CLEARNACE.

INTAKE PIPE SIZE TABLE (SEE NOTE 8)			
UNIT SIZE	PIPE LENGTH		
	0 - 75'	76' - 250'	251' - 400'
TPX 5	2.00"	2.50"	3.00"
	PIPE LENGTH		
	0 - 100'	101' - 250'	251' - 400'
TPX 7.5	2.50"	3.00"	3.50"


EFFECTIVE PIPE LENGTH FOR ELBOWS				
PIPE SIZE (IN)	2.00" NPT	2.50" NPT	3.00" NPT	3.50" NPT
EFF. PIPE LENGTH (FT)	4.9	6.4	7.9	9.4

D

C


B

A

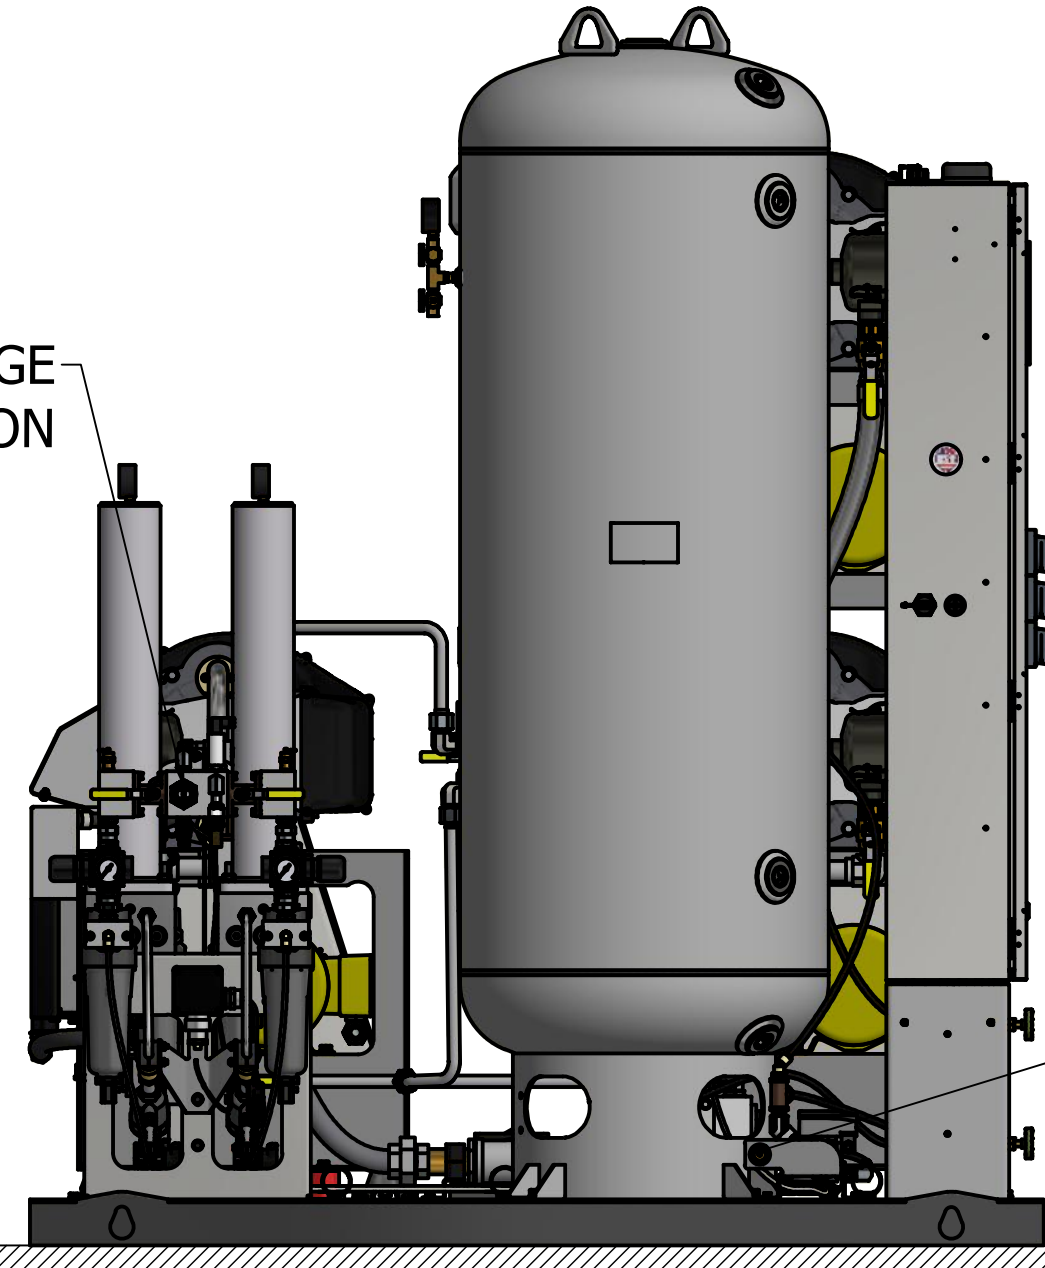

NO VIBRATION PADS ARE NECESSARY AT THIS LOCATION



NO FOUNDATION OR INERTIA PAD IS REQUIRED (HOUSEKEEPING PAD IS OPTIONAL)

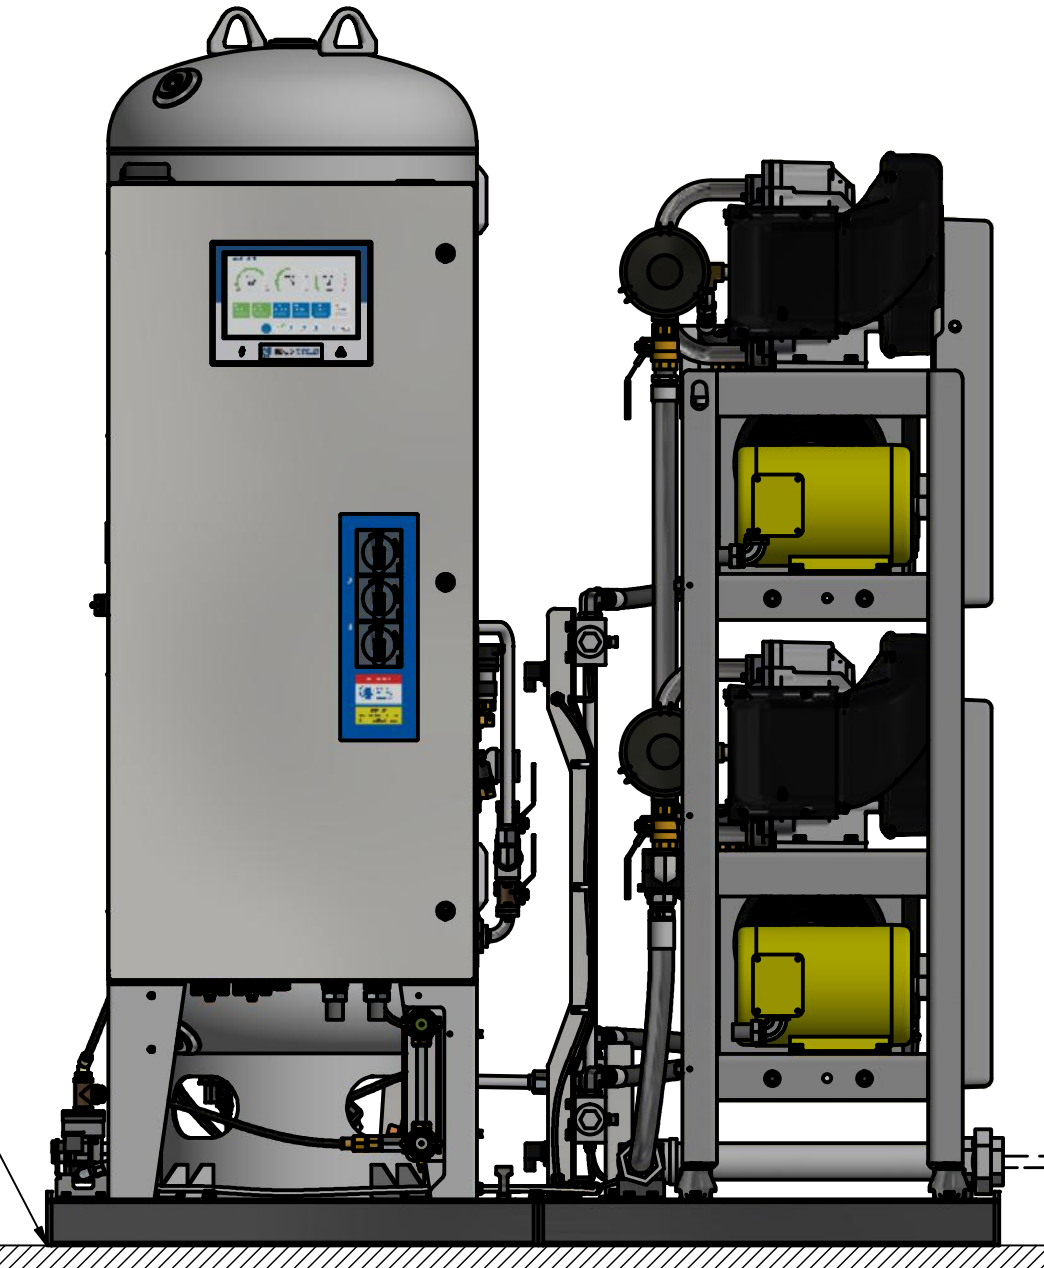

ETHERNET WIRING ACCESS

ALARM WIRING ACCESS

SINGLE POINT POWER WIRING ACCESS

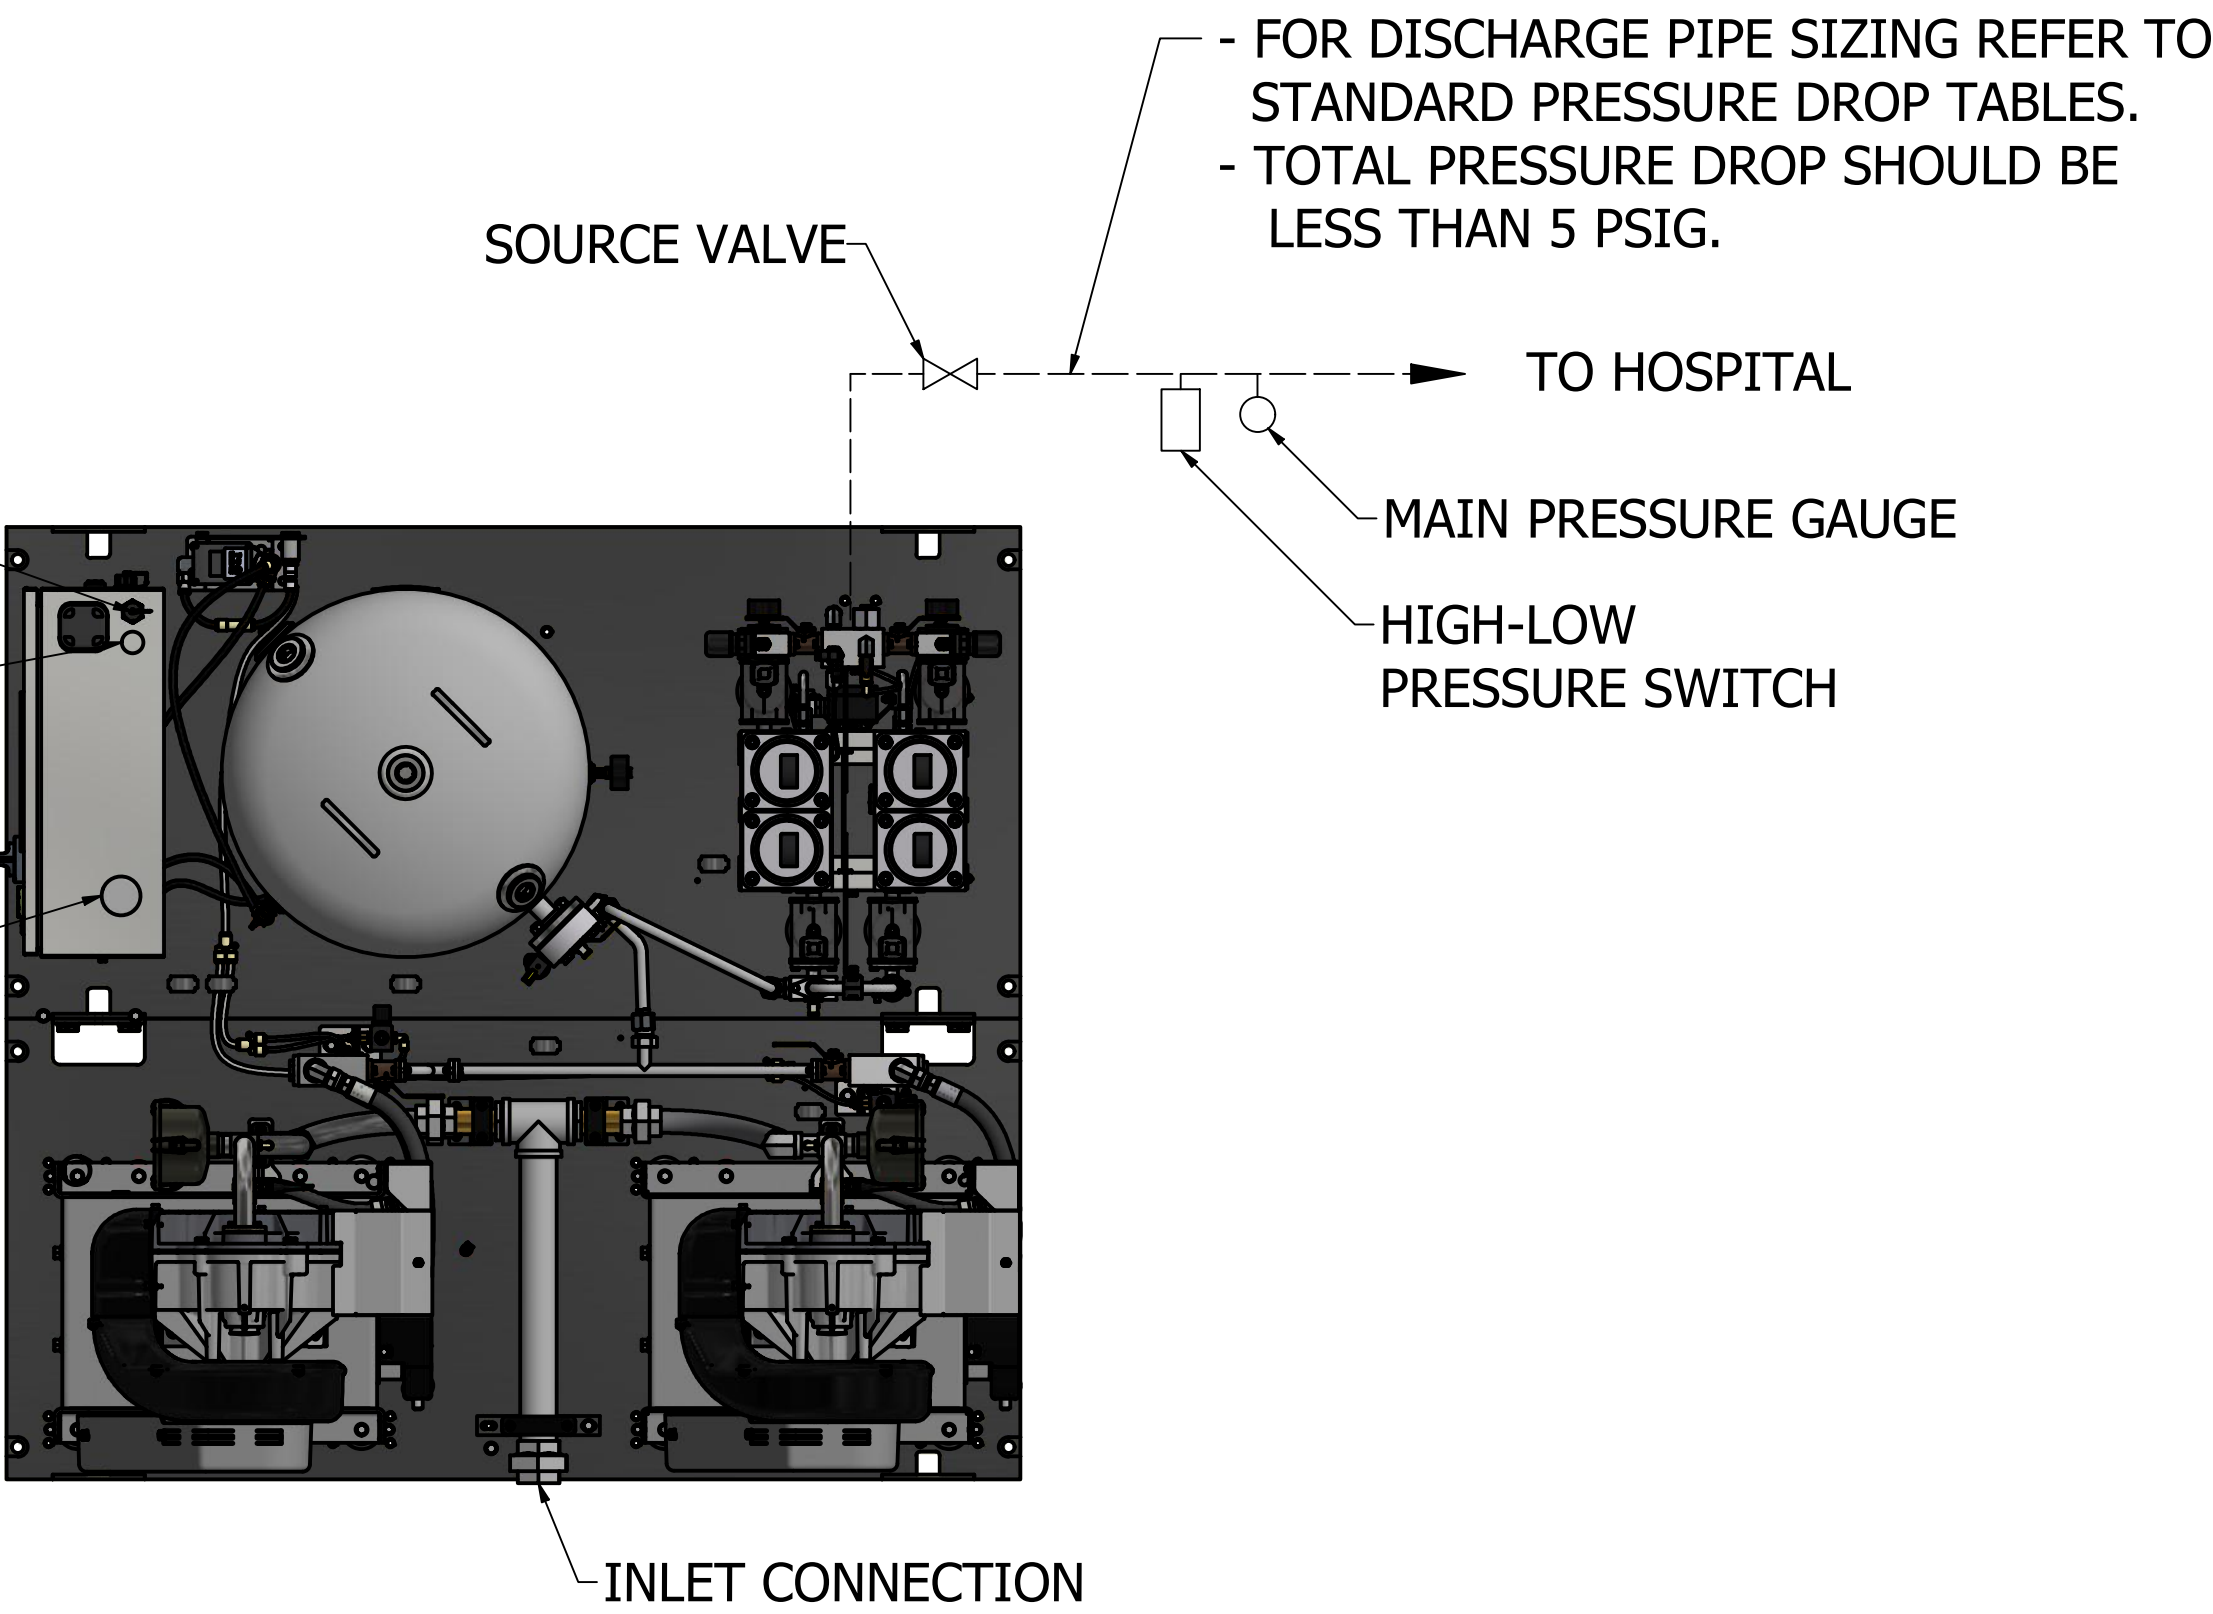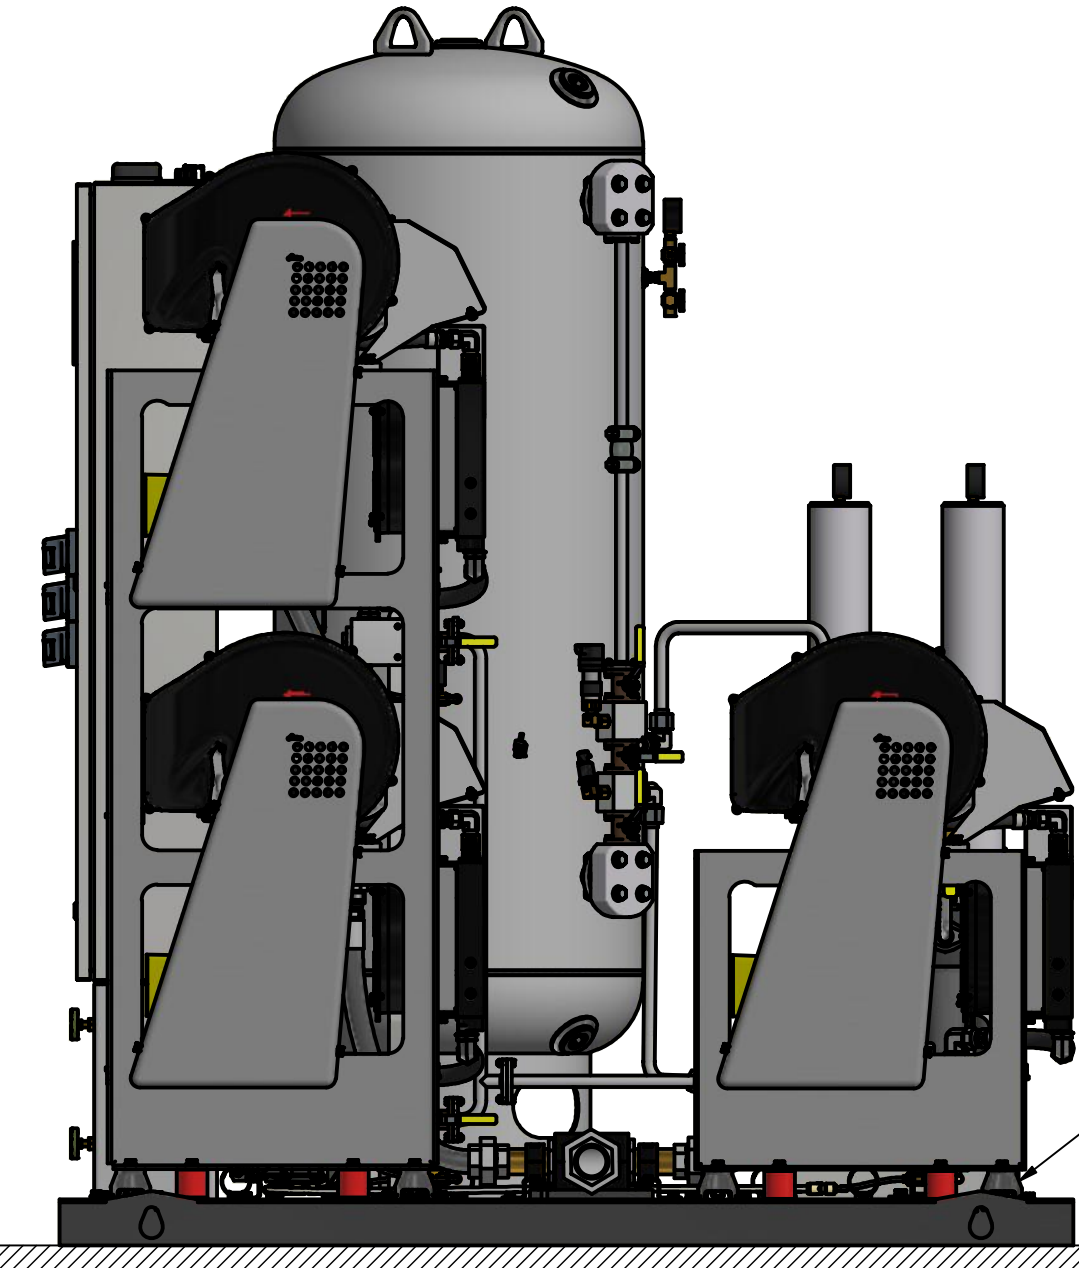

NOTE:

ALL ACCESSORIES, PIPE, AND FITTINGS BEYOND INLET AND DISCHARGE PORTS ARE SUPPLIED AND INSTALLED BY OTHERS.

Revised: APS	Date: 3/1/2023	Drawn: JDY	Date: 10/28/2009
Description: INST DIA - LL TPX SCROLL AIR SPC 5-7.5Hp NFPA W/ DESC DRYERS		Part Number: 4107 8511 87	
DN: HOP230837		Rev: 03	
Sheet 1 of 1		DO NOT SCALE THIS DOCUMENT	

(7.5HP WITH 120 GALLON RECEIVER SHOWN)

A